
 
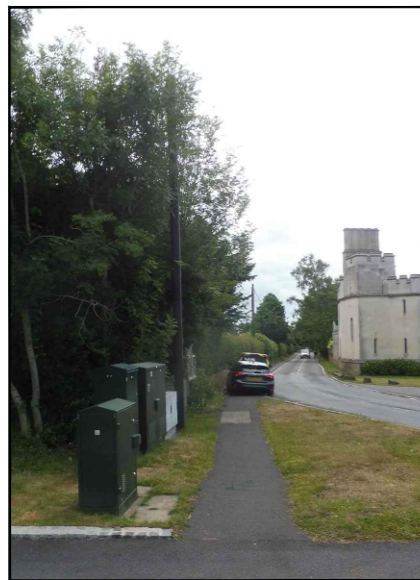


Reproduced by permission of Ordnance Survey on behalf of the Controller of Her Majesty's Stationery Office
All rights reserved. © Crown Copyright licence no. 100022432

SITE AREA PLAN



 
SITE PHOTOGRAPH

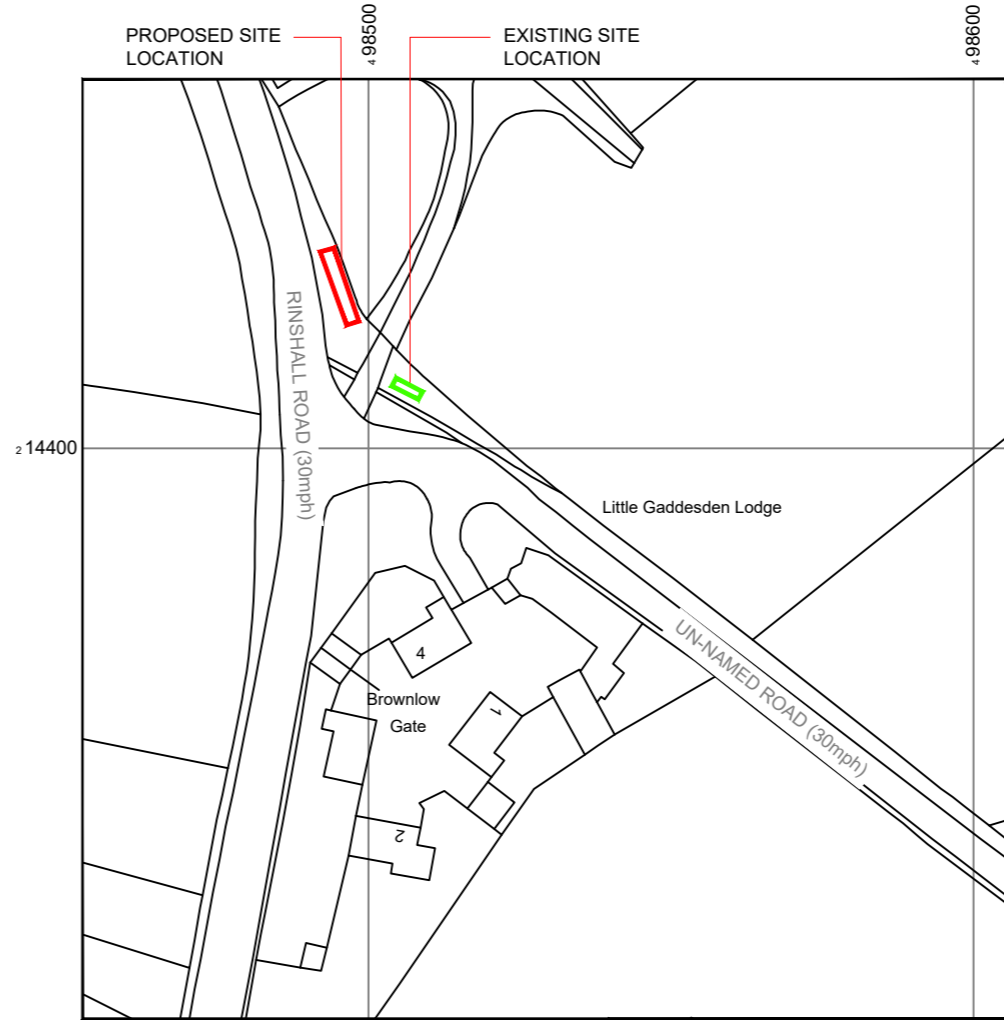

Reproduced by permission of Ordnance Survey on behalf of the Controller of Her Majesty's Stationery Office
All rights reserved. © Crown Copyright licence no. 100022432

NGR E: 498511 N: 214406 (Extg)
NGR E: 498497 N: 214423 (Prop)

SITE LOCATION PLAN



GOOGLE MAPS QR CODE

GOOGLE MAPS - [Hyperlink to plan view of the site](#)

GOOGLE STREETVIEW - [Hyperlink to streetview of the site](#)

NOTES:

1. ALL DIMENSIONS IN MM UNLESS OTHERWISE NOTED.

DIRECTIONS TO SITE:

Head south on M1. Take the A5183 exit towards St Albans(N) After 0.4 miles at the roundabout, take the 2nd exit onto A5183. At the roundabout, take the 2nd exit and stay on A5183. After 2 miles turn left onto Hicks Rd then turn right onto High St. Turn left onto Buckwood Rd and after 1.8 miles turn left onto Byslips Rd. Continue straight onto Common Rd and continue onto Studham Ln and at T junction turn left onto Dunstable Rd/B4506. Continue onto Ringshall Rd and site will be on left after 1.7 miles

Existing Site Boundary:



Proposed Site Boundary:



Access Route To Site:



Access Route:



Master:	MBNL / EE / H3G:	Project:	Purpose of Issue:	Issue:
M001	MBNL	3UK BUY-IN	Planning	A
Date:	31.08.2022	Revision / Upgrade Description:		
Drawn:	M.Williams	First Issue - For comments		
Checked:	A.Dobson			
Approved:	A.Dobson			

Hutchison 3G UK Limited
Green Park, 450 Longwater Avenue
Reading, RG30 3UR
Tel: 01628 785 000
Fax: 01628 785 001

Hatfield Business Park
Hatfield
Hertfordshire
AL10 9BW
Tel: 01707 315000
Fax: 01707 319001

Mobile Broadband Network Limited
Sixth Floor, Thames Tower, Station Road, Reading, RG1 1LX

Design Consultant & Principal Contractor:

Unit E, Madison Place, Northampton Road,
Manchester, M40 5AG
Tel: 0161 785 4500 Fax: 0161 785 4501
Web: www.clarke-telecom.com

Site Name: **RINGSALL ROAD LP**

Site ID: **1206131**

Address: **RINGSALL ROAD
RINGSALL
BERKHAMSTED
HERTFORDSHIRE
HP4 1ND**

Title: **002 SITE LOCATION PLAN**


Project: **3UK BUY-IN**

Purpose of Issue: **PLANNING**

EE Cell ID:	MBNL Cell ID:	3UK Cell ID:
16997	DAC061	HP0395

Master Drawing No: **1206131_DAC061_16997_HP0395_M001** Issue: **A**

100mm
150mm
10mm

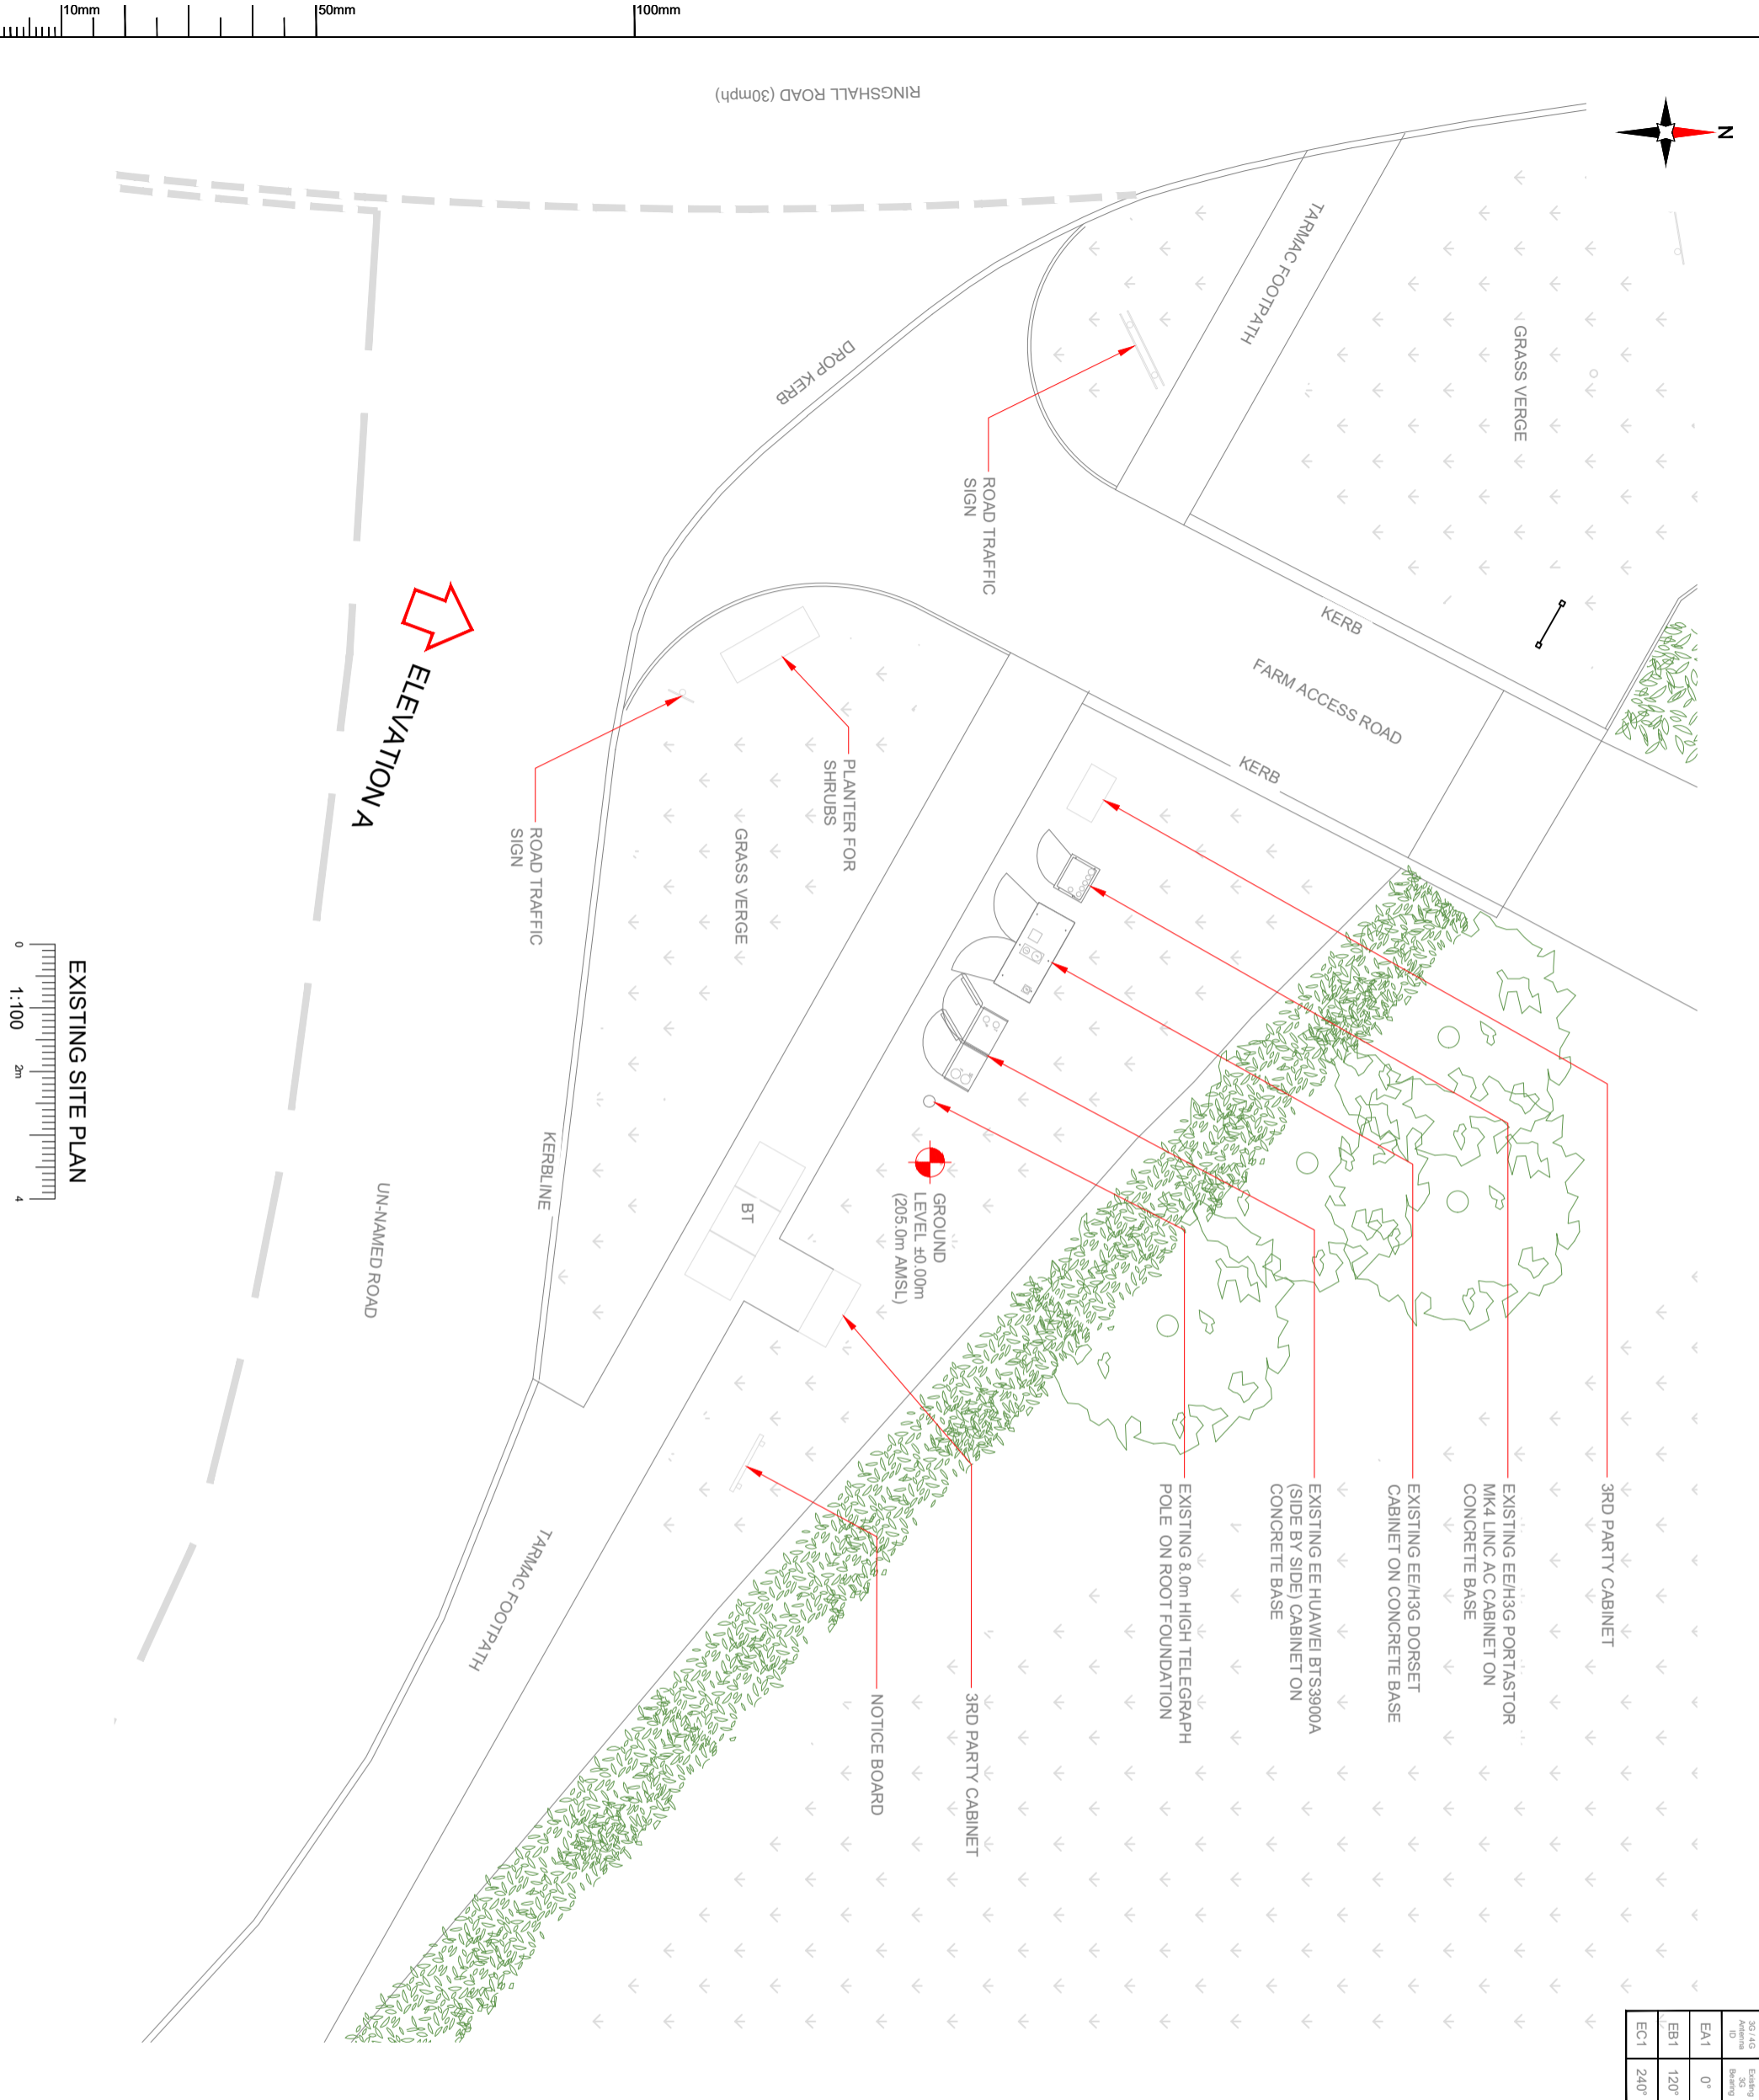

Existing Feature ID	Existing Bearing
EA1	0°
EB1	120°
EC1	240°

NOTES:
1. ALL DIMENSIONS IN MM UNLESS OTHERWISE NOTED.

Master: MBNL/EE/HQ3	Project: 3UK BUY-IN	Purpose of Issue: Planning	Issue: A
M001	MBNL	3UK BUY-IN	Planning
Date: 31.08.2022	Revision / Upgrade Description: First Issue - For comments		
Drawn: M. Williams	Checked: M. Williams	Approved: Addison	

3UK
3UK Base Station Information line
0844 804000
Address to Ring - M20 to Ring

EE
Tel: 01707 315000
Fax: 01707 319001

MBNL
Mobile Broadband Network Limited
Sixth Floor, Thames Tower, Station Road, Reading, RG1 1LX

Design Consultant & Principal Contractor:


Unit E, Madison Place, Northampton Road,
Manchester, M40 5AG
Tel: 0161 785 4500 Fax: 0161 785 4501
Web: www.clarke-telecom.com

Site Name: RINGSHALL ROAD LP
Site ID: 1206131



Address: RINGSHALL ROAD
RINGSHALL
BERKHAMSTED
HERTFORDSHIRE
HP4 1ND

Title: 100 EXISTING SITE PLAN
Project: 3UK BUY-IN

Purpose of Issue: PLANNING			
EE Call ID: 16997	MBNL Call ID: DAC061	3UK Call ID: HP0395	Issue: A
Master Drawing No: 1206131_DAC061_16997_HP0395_M001			

 

EXISTING SITE PLAN
0 1:100 2m 4

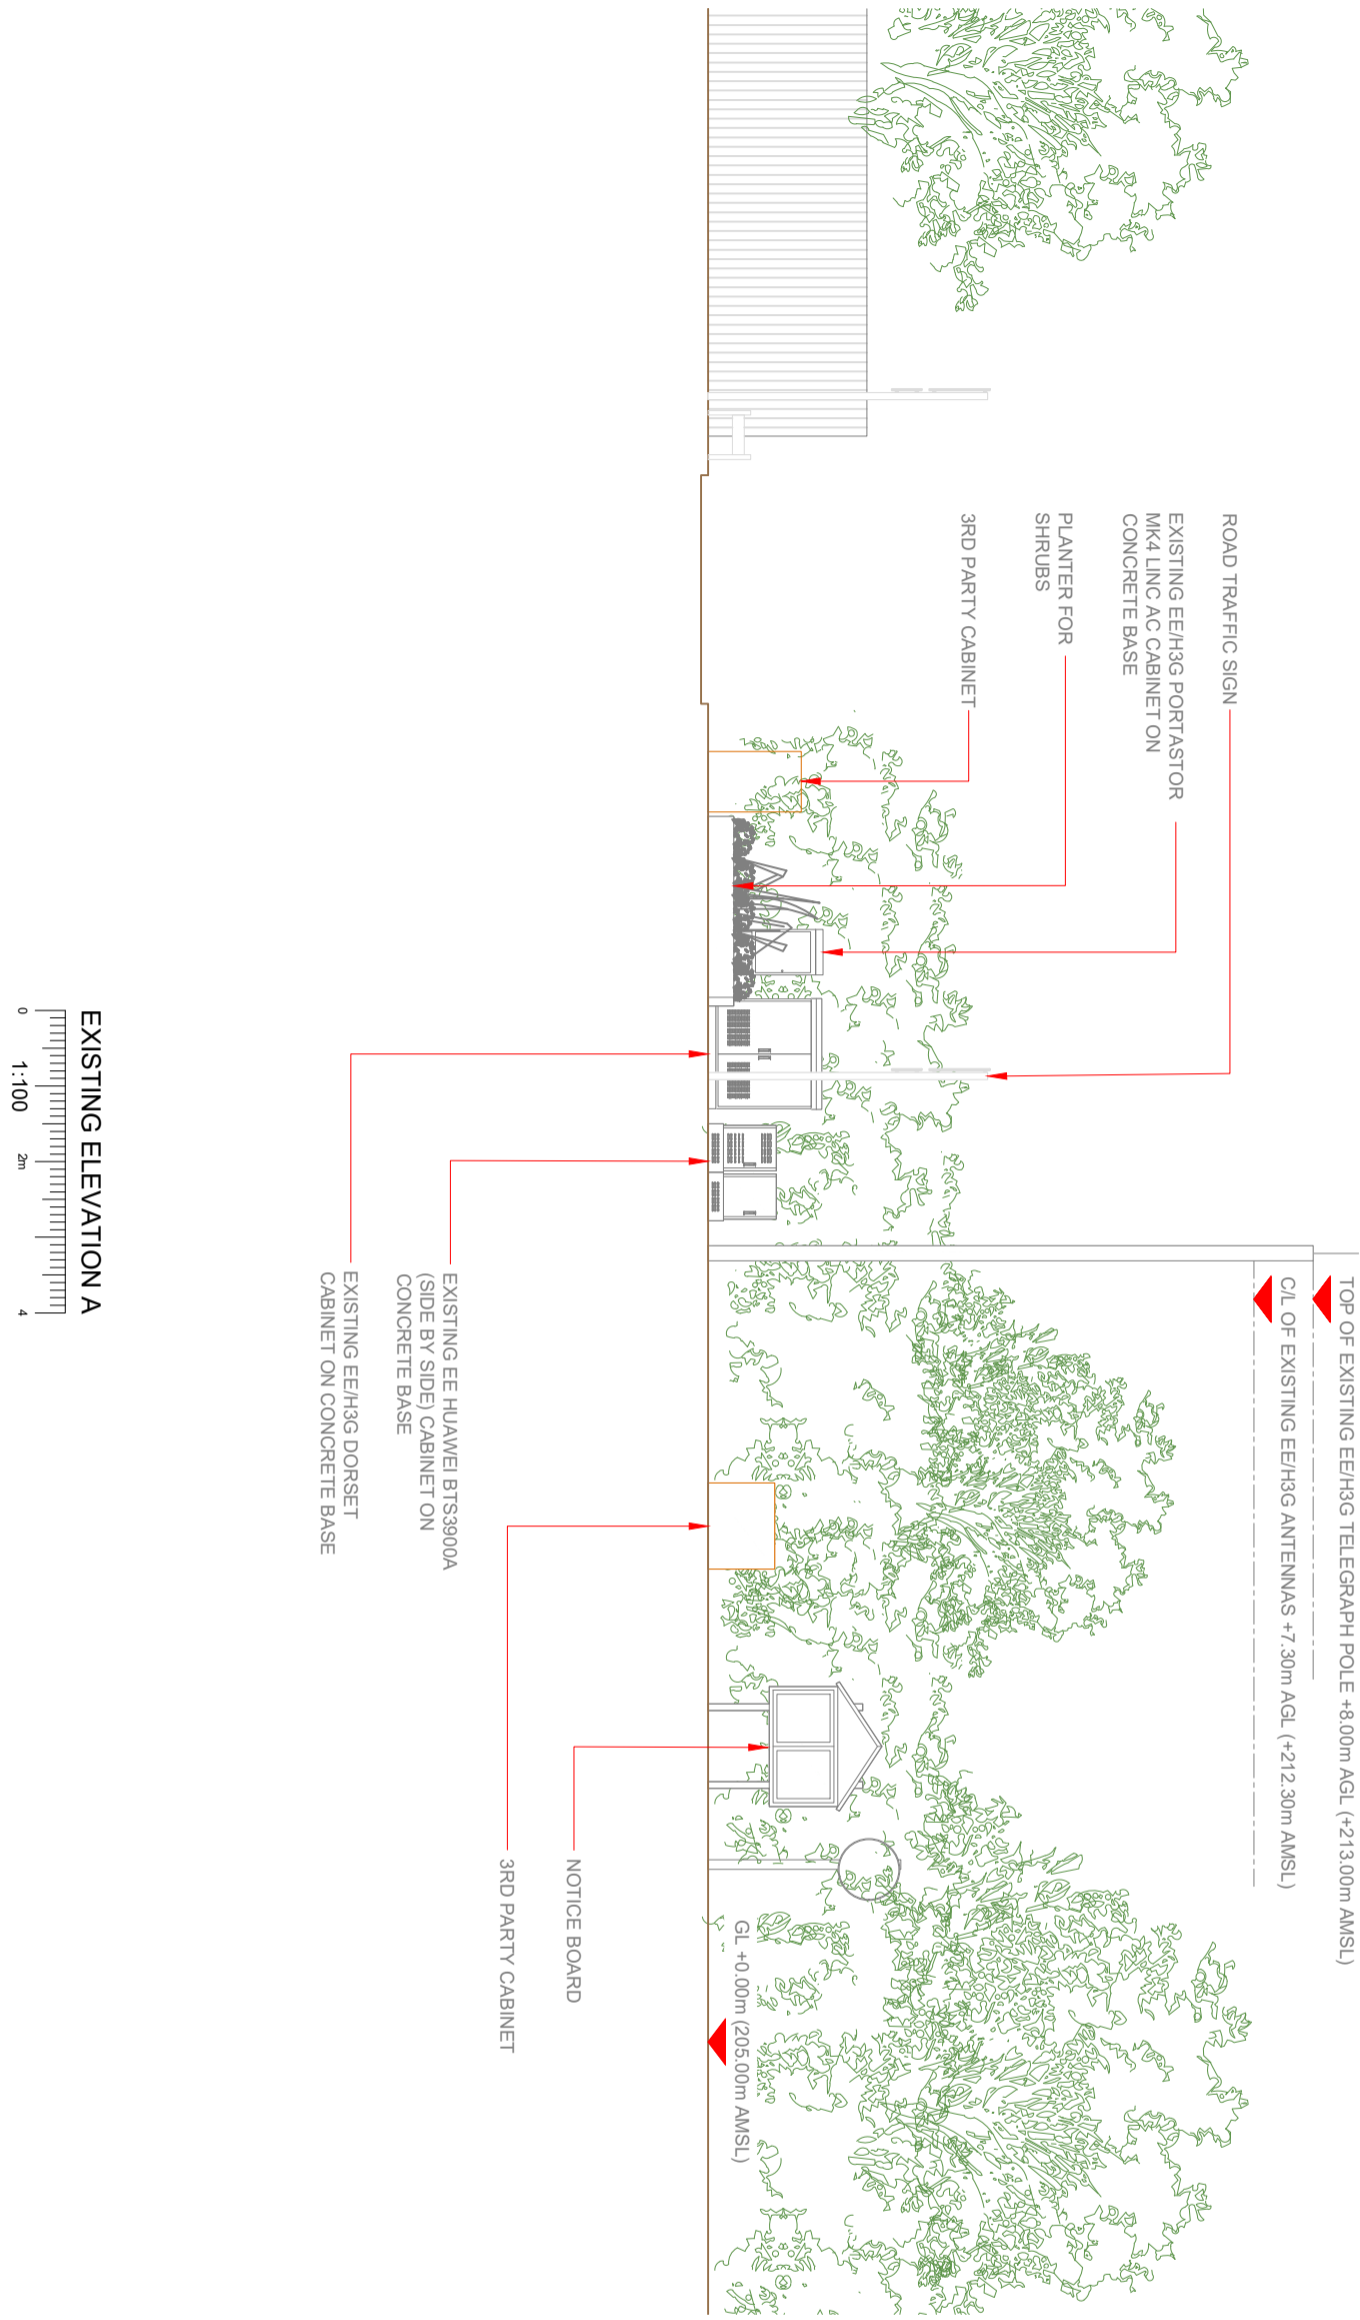 

EXISTING ELEVATION A
0 1:100 2m 4

202143	202143	07
001	001	0°
EA1	EA1	120°
EB1	EB1	240°
EC1	EC1	

NOTES:
1. ALL DIMENSIONS IN MM UNLESS OTHERWISE NOTED.

Master: MBNL/EE/H3G		Project: 3UK BUY-IN		Purpose of Issue: Planning		Issue: A	
M001		MBNL		3UK BUY-IN		Planning	
Date: 31.08.2022		Revision / Upgrade Description: First Issue - For comments					
Drawn: M.Williams		Checked: A.Dobson		Approved: A.Dobson			
<p>Hutchison 3G UK Limited Greenhill, 403, Longwalk Avenue Reading RG2 3JH Tel: 01628 90000 Fax: 01628 90000 3UK Base Station Information line 0844 842000 Address to: enquiries@h3g.co.uk</p>				<p>EE Tel: 01707 315000 Fax: 01707 319001</p>			
<p>Mobile Broadband Network Limited Skin Floor, Thames Tower, Station Road, Reading, RG1 1LX</p>							
<p>Design Consultant & Principal Contractor: Unit E, Madison Place, Northampton Road, Manchester, M40 5AG Tel: 0161 785 4500 Fax: 0161 785 4501 Web: www.clarke-telecom.com</p>							
Site Name:		RINGSHALL ROAD LP					
Site ID:		1206131					
Address:		RINGSHALL ROAD RINGSHALL BERKHAMSTED HERTFORDSHIRE HP4 1ND					
Title:		150 EXISTING ELEVATION A					
Project:		3UK BUY-IN					
Purpose of Issue:		PLANNING					
EE Call ID:		MBNL Call ID:		3UK Call ID:			
16997		DAC061		HP0395			
Master Drawing No:		1206131_DAC061_16997_HP0395_M001		Issue:		A	



Antenna Aperture ID	Proposed 4G/5G Bearing	Operator Shared/ EPH/SG
A1	0°	3UK/EE
A2	0°	3UK/EE
B1	120°	3UK/EE
B2	120°	3UK/EE
C1	240°	3UK/EE
C2	240°	3UK/EE

NOTES:
1. ALL DIMENSIONS IN MM UNLESS OTHERWISE NOTED.

NOTE: 600x600 PAVING STONES TO BE LAID IN FRONT OF ALL PROPOSED EQUIPMENT CABINETS AS SHOWN

CLOSE BOARD TIMBER FENCE

PROPOSED 3UK BOWLER EQUIPMENT CABINET TO BE INSTALLED ON NEW COMBINED ROOT FOUNDATION

PROPOSED 3UK ERICSSON RBS6130 CABINET TO BE INSTALLED ON ADAPTER PLATE ON COMBINED ROOT FOUNDATION

PROPOSED 18.00m HIGH EE/3UK PHASE 7 HS2 SW POLE (20.0m POLE WITH 2.0m LONG SPINE REMOVED FROM TOP), TO BE INSTALLED ON ROOT FOUNDATION C/W PROPOSED WRAPAROUND CABINET AT BASE OF POLE & 3UK GPS NODE AT TOP

EXISTING RELOCATED EE HUawei BTS3900A SIDE BY SIDE EQUIPMENT CABINETS TO BE INSTALLED ON NEW ROOT FOUNDATION


PROPOSED 3UK KOMODO CABINET TO BE INSTALLED ON NEW ROOT FOUNDATION

PROPOSED 3UK/EE TTRY MK5b LINK/AC CABINET TO BE INSTALLED ON NEW ROOT FOUNDATION

NOTE: SPEED LIMIT INCREASES TO 40mph NORTH OF THIS SIGN

SPEED LIMIT SIGN

ELEVATION B

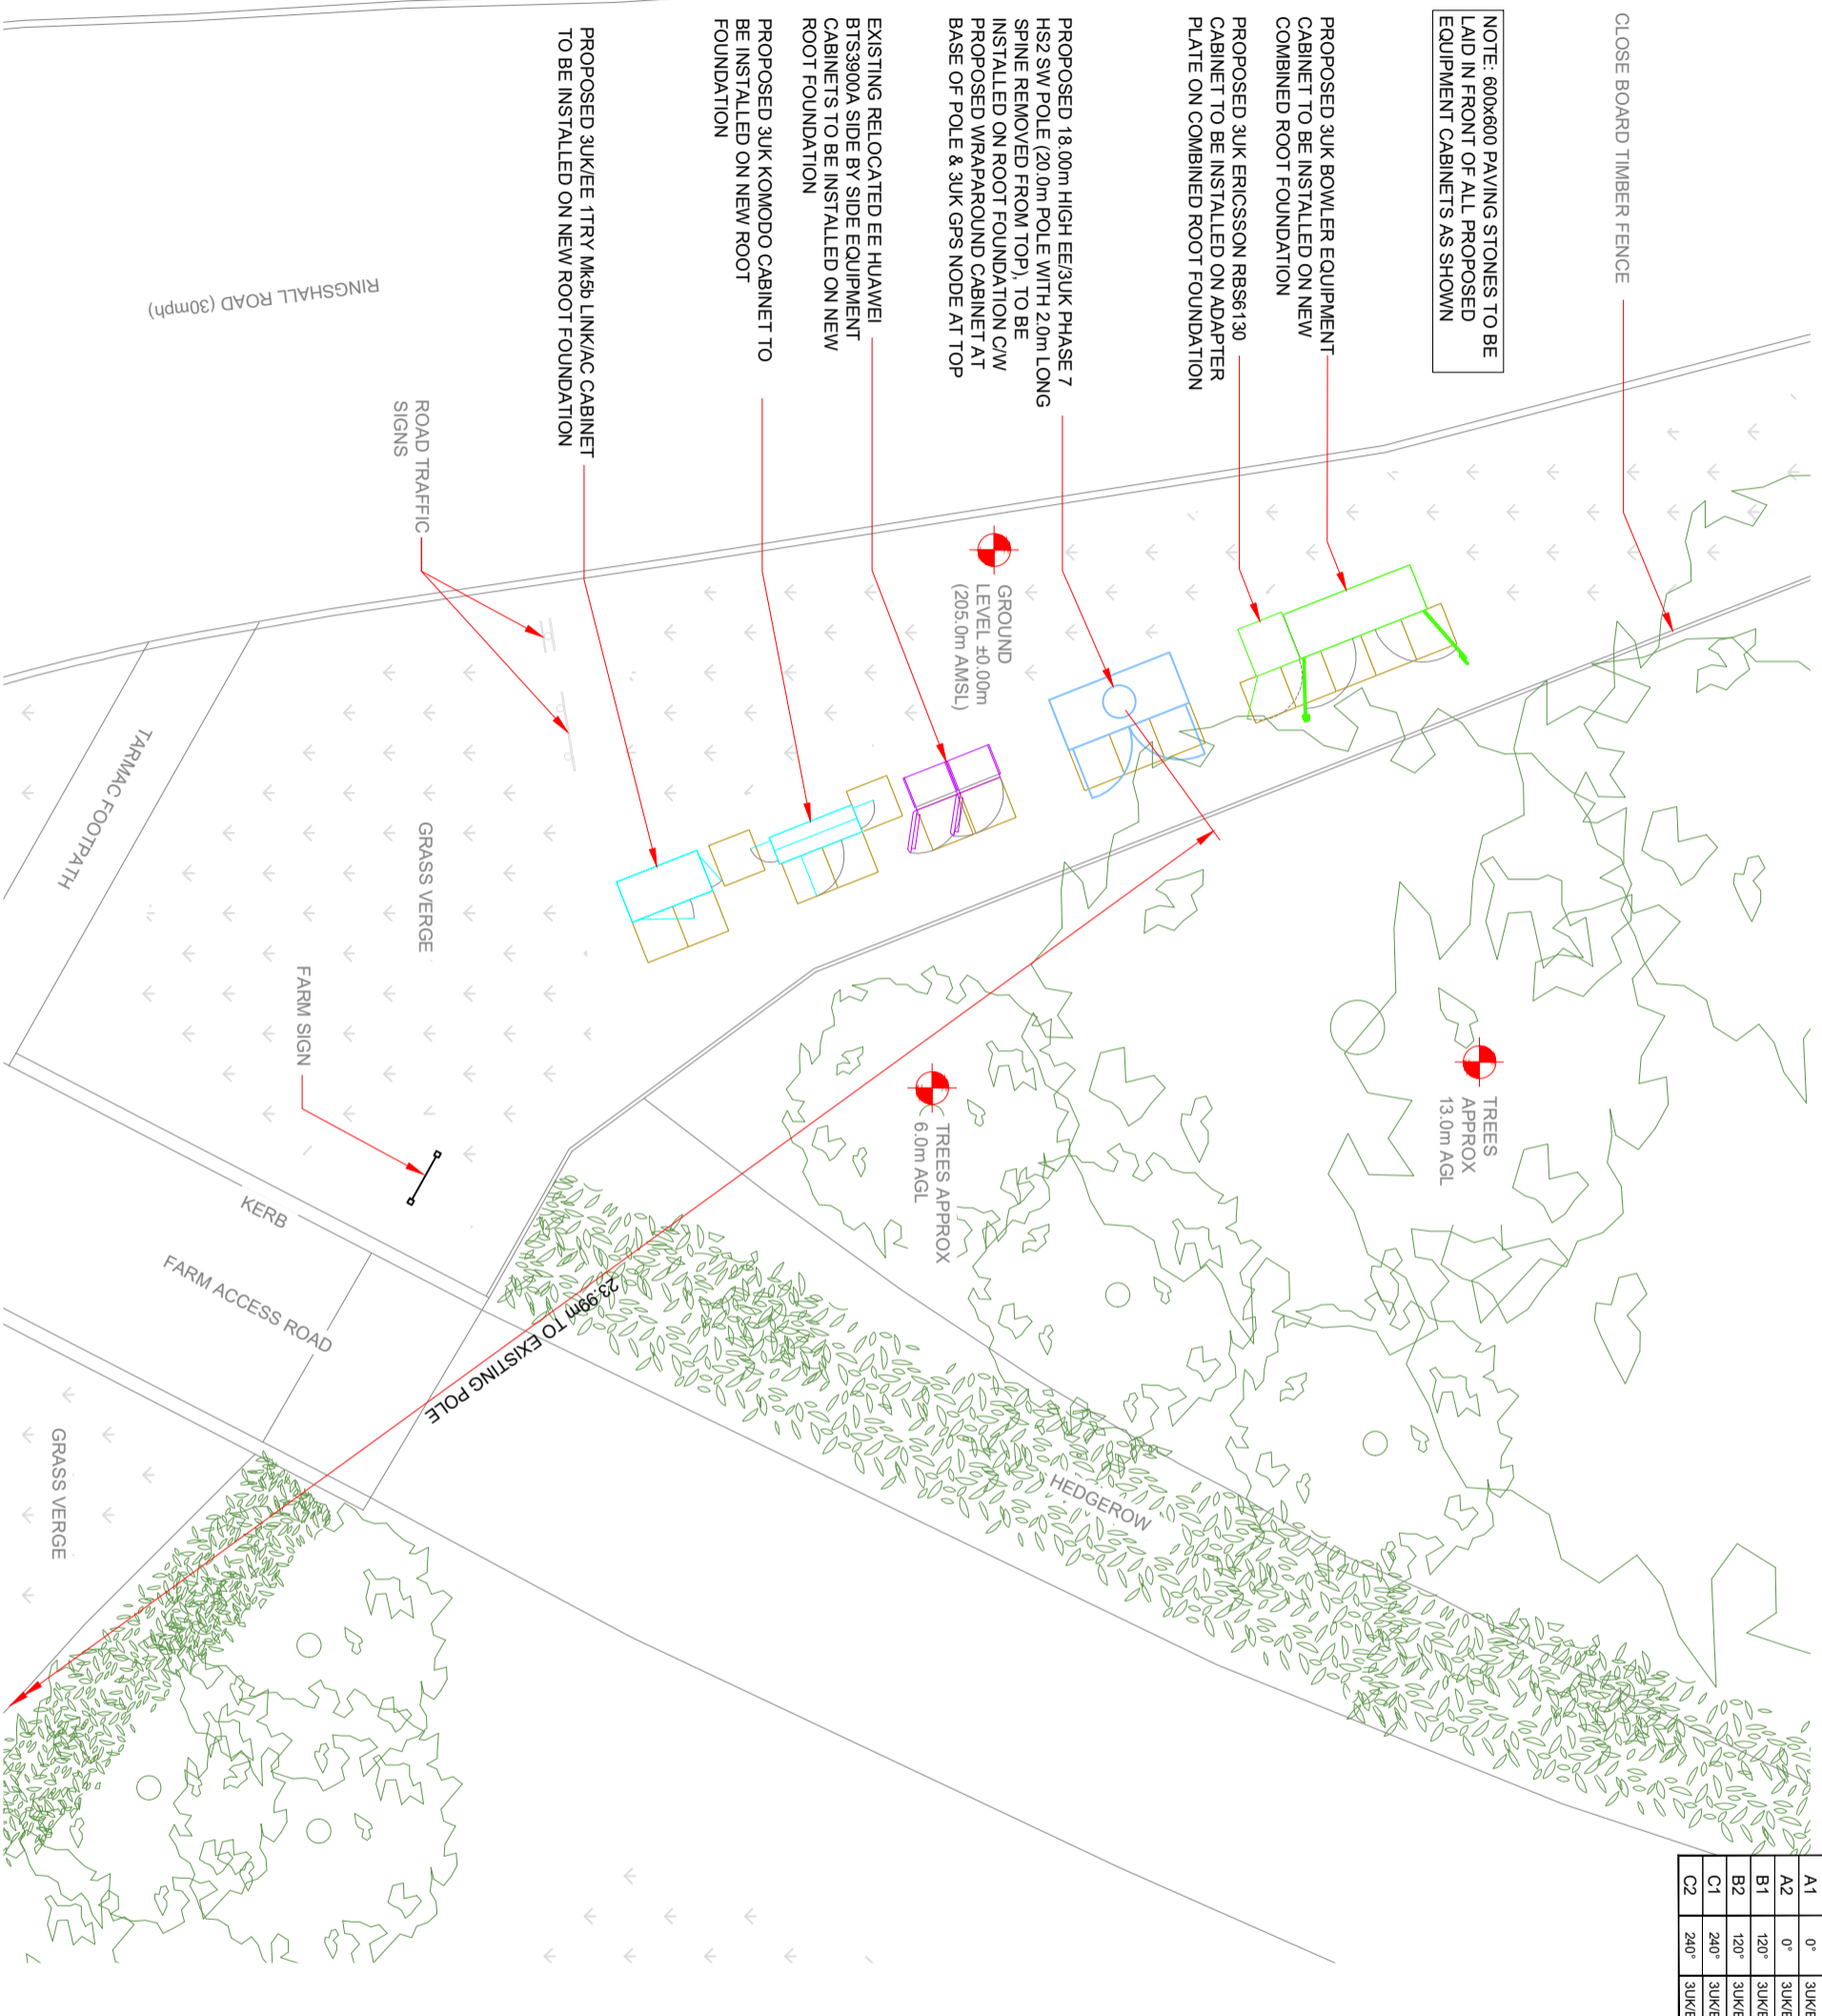

PROPOSED SITE PLAN
1:100
0 2m 4

Master: MBNL/EE/HQS	Project: 3UK BUY-IN	Purpose of Issue: Planning	Issue: A
M001	MBNL	3UK BUY-IN	Planning
Date: 31/08/2022	Revision / Upgrade Description: First Issue - For comments		
Drawn: M.Williams	Checked: Addison		
Approved: Addison			

Hutchison 3G UK Limited
General Theatrical Centre
Rensley Road 3/4
The Oriel Centre
London E1 6RN
Tel: 01753 821000
Mobile: 07797 319001

EE
Tel: 01707 315000
Fax: 01707 319001

Mobile Broadband Network Limited
Skin Floor, Thames Tower, Station Road, Reading, RG1 1LX
Design Consultant & Principal Contractor:

Unit E, Madison Place, Northampton Road,
Manchester, M40 5AG
Tel: 0161 785 4500 Fax: 0161 785 4501
Web: www.clarke-telecom.com

Site Name: RINGSHALL ROAD LP
Site ID: 1206131

Address: RINGSHALL ROAD
RINGSHALL
BERKHAMSTED
HERTFORDSHIRE
HP4 1ND

Title: 215 PROPOSED SITE PLAN


Project: 3UK BUY-IN

Purpose of Issue: PLANNING

EE Call ID: 16997	MBNL Call ID: DAC061	3UK Call ID: HP0395
Master Drawing No: 1206131_DAC061_16997_HP0395_M001	Issue: A	

Antenna ID	Aperture	4G/5G Sharing	Operator
A1	0°	3UK/EE	3UK/EE
A2	0°	3UK/EE	3UK/EE
B1	120°	3UK/EE	3UK/EE
B2	120°	3UK/EE	3UK/EE
C1	240°	3UK/EE	3UK/EE
C2	240°	3UK/EE	3UK/EE

NOTES:
1. ALL DIMENSIONS IN MM UNLESS OTHERWISE NOTED.

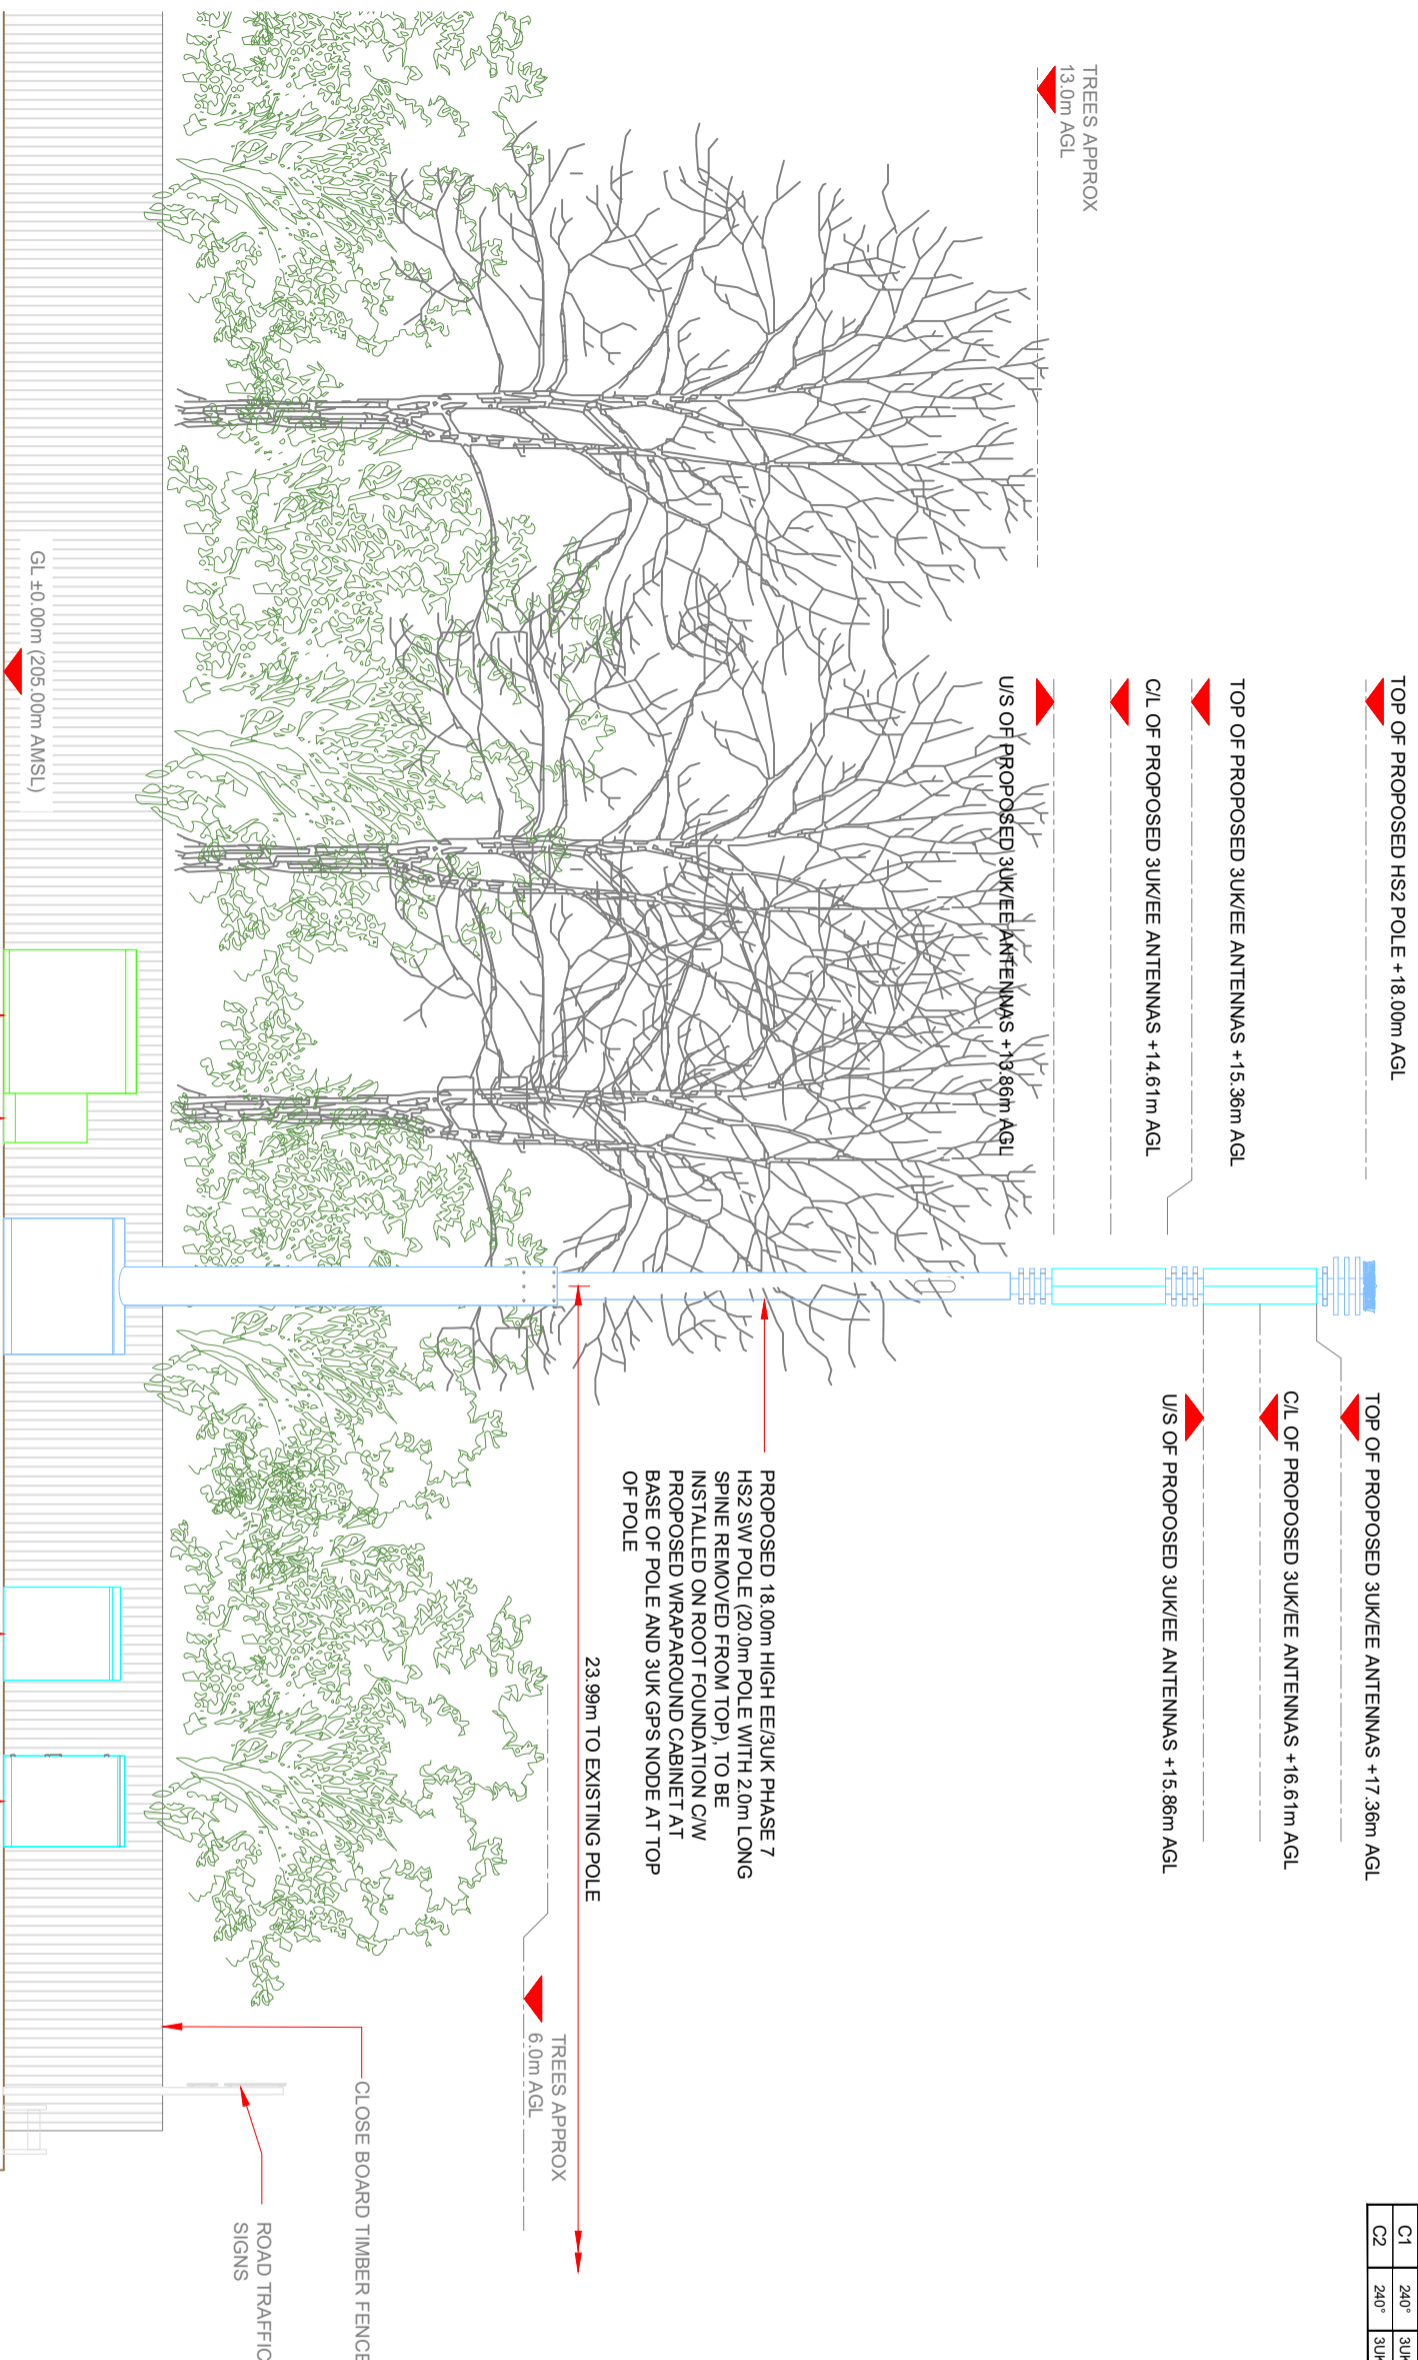

Master: MBNL/EE/HQ	Project: 3UK BUY-IN	Purpose of Issue: Planning	Issue: A
M001	MBNL	3UK BUY-IN	Planning
Date: 31.08.2022	Revision / Upgrade Description: First Issue - For comments		
Drawn: M. Williams	Checked: Addison		
Approved: Addison			
 Hutchison 3G UK Limited Queens Walk, 403, Cornhill Avenue Reading, RG2 3JH Tel: 0118 950000 Fax: 0118 950000 www.h3g.co.uk		 EE Hatfield Business Park Hatfield Hertfordshire AL10 9BW Tel: 01707 315000 Fax: 01707 319001	
MBNL Mobile Broadband Network Limited Skin Floor, Thames Tower, Station Road, Reading, RG1 1LX Design Consultant & Principal Contractor:			
 CLARKE telecom Unit E, Madison Place, Northampton Road, Manchester, M40 5AG Tel: 0161 785 4500 Fax: 0161 785 4501 Web: www.clarke-telecom.com			
Site Name:	RINGSALL ROAD LP		
Site ID:	1206131		
Address:	RINGSALL ROAD RINGSALL BERKHAMSTED HERTFORDSHIRE HP4 1ND		
Title:	265 PROPOSED ELEVATION B		
Project:	3UK BUY-IN		
Purpose of Issue:	PLANNING		
EE Call ID:	MBNL Call ID:	3UK Call ID:	
16997	DAC061	HP0395	
Master Drawing No:	1206131_DAC061_16997_HP0395_M001		Issue: A